


**LED Floodlighting & Bracket**

Scale: NTS

Dimensions shown in millimeters (mm).

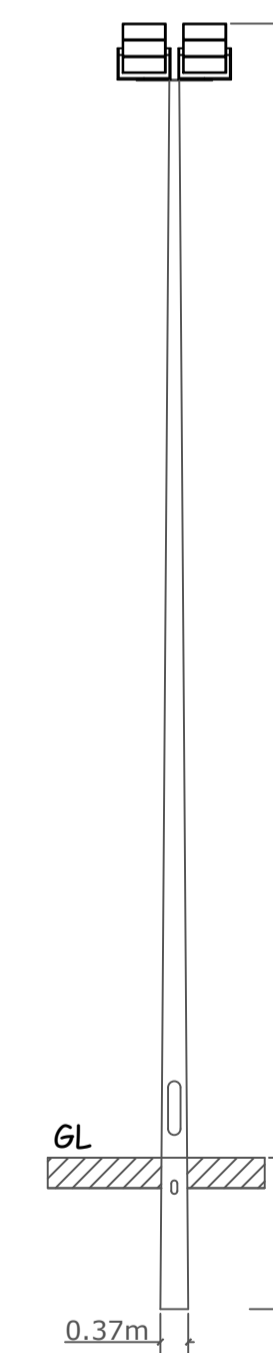

**15m High Floodlight Pole**  
Scale: 1:100

**Pitch Lighting - Overspill Iso Contours**  
Scale 1:500

**LEGEND**

- BVP528 OUT T35 A55-NB LO →
- Proposed Floodlight ● FL
- Surface Illumance (lux) Contour —25—
- Existing Tree ●

DESCRIPTION	CHK	STA	DATE	REV

NOTES:

PROJECT: Doughiska Pitches Floodlighting	LOCATION: Doughiska Road, Galway
DRAWING: Proposed Lighting Layout	DWG NO.: PK524-02-003
PROJECT NO.: PKSCAP24-02	SCALE: 1:500 @ A1
DATE: Feb 2025	DRAWN BY: KM APPROVED BY: JB