


Pitch Lighting - Overspill Iso Contours
Scale 1:500


LEGEND

- BVP528 OUT T35 A55-NB LO
- Proposed Floodlight
- Surface Illumance (lux) Contour

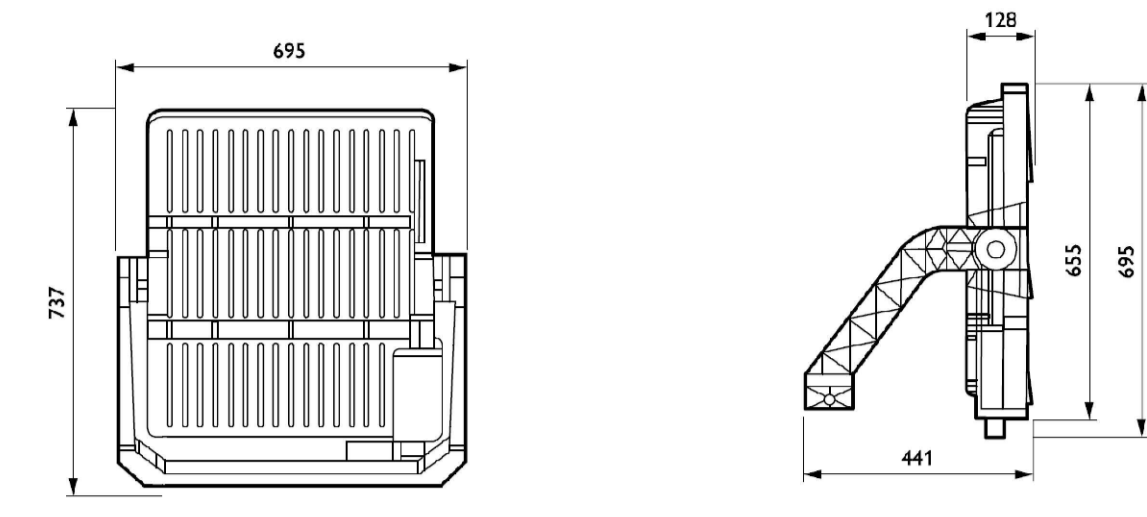

LED Floodlighting & Bracket
Scale: NTS

Dimensions shown in millimeters (mm).

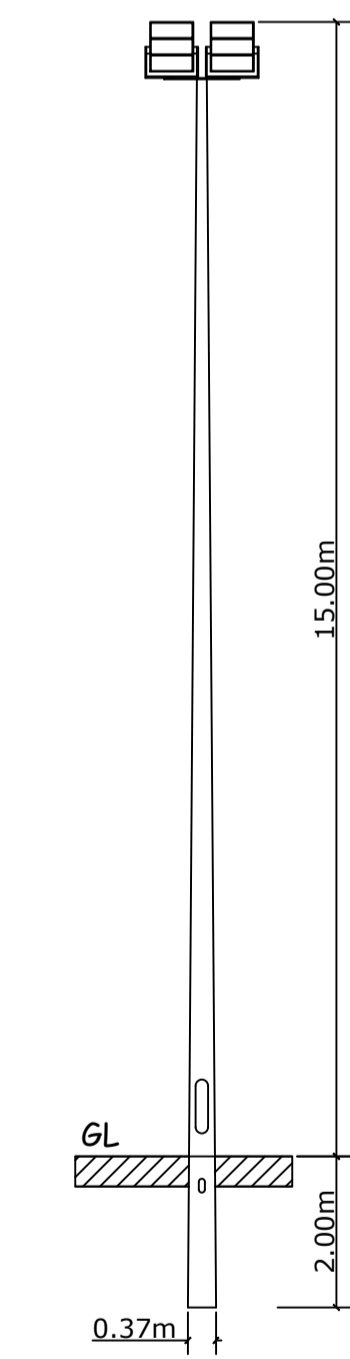

15m High Floodlight Pole
Scale: 1:100

| DESCRIPTION | CHK | STA | DATE | REV |
|-------------|-----|-----|------|-----|
| | | | | |
| | | | | |
| | | | | |

NOTES:
 DO NOT SCALE FROM THIS DRAWING. WORK ONLY FROM FIGURED DIMENSIONS.
 ALL ERRORS AND OMISSIONS TO BE REPORTED TO THE DESIGNER.
 EXTRACT D.S. SHEETS 3409 01 & 3409 06
 © ORDNANCE SURVEY IRELAND. ALL RIGHTS RESERVED.

| | |
|--------------------------------------|---------------------------|
| PROJECT: Melodys Field Floodlighting | LOCATION: Renmore, Galway |
| DRAWING: Proposed Lighting Layout | DWG NO.: PKS24-09-003 |
| PROJECT NO.: PKSCAP24-09 | SCALE: 1:500 @ A1 |
| DATE: May 2025 | REV: A |
| DRAWN BY: KM | APPROVED BY: JB |