

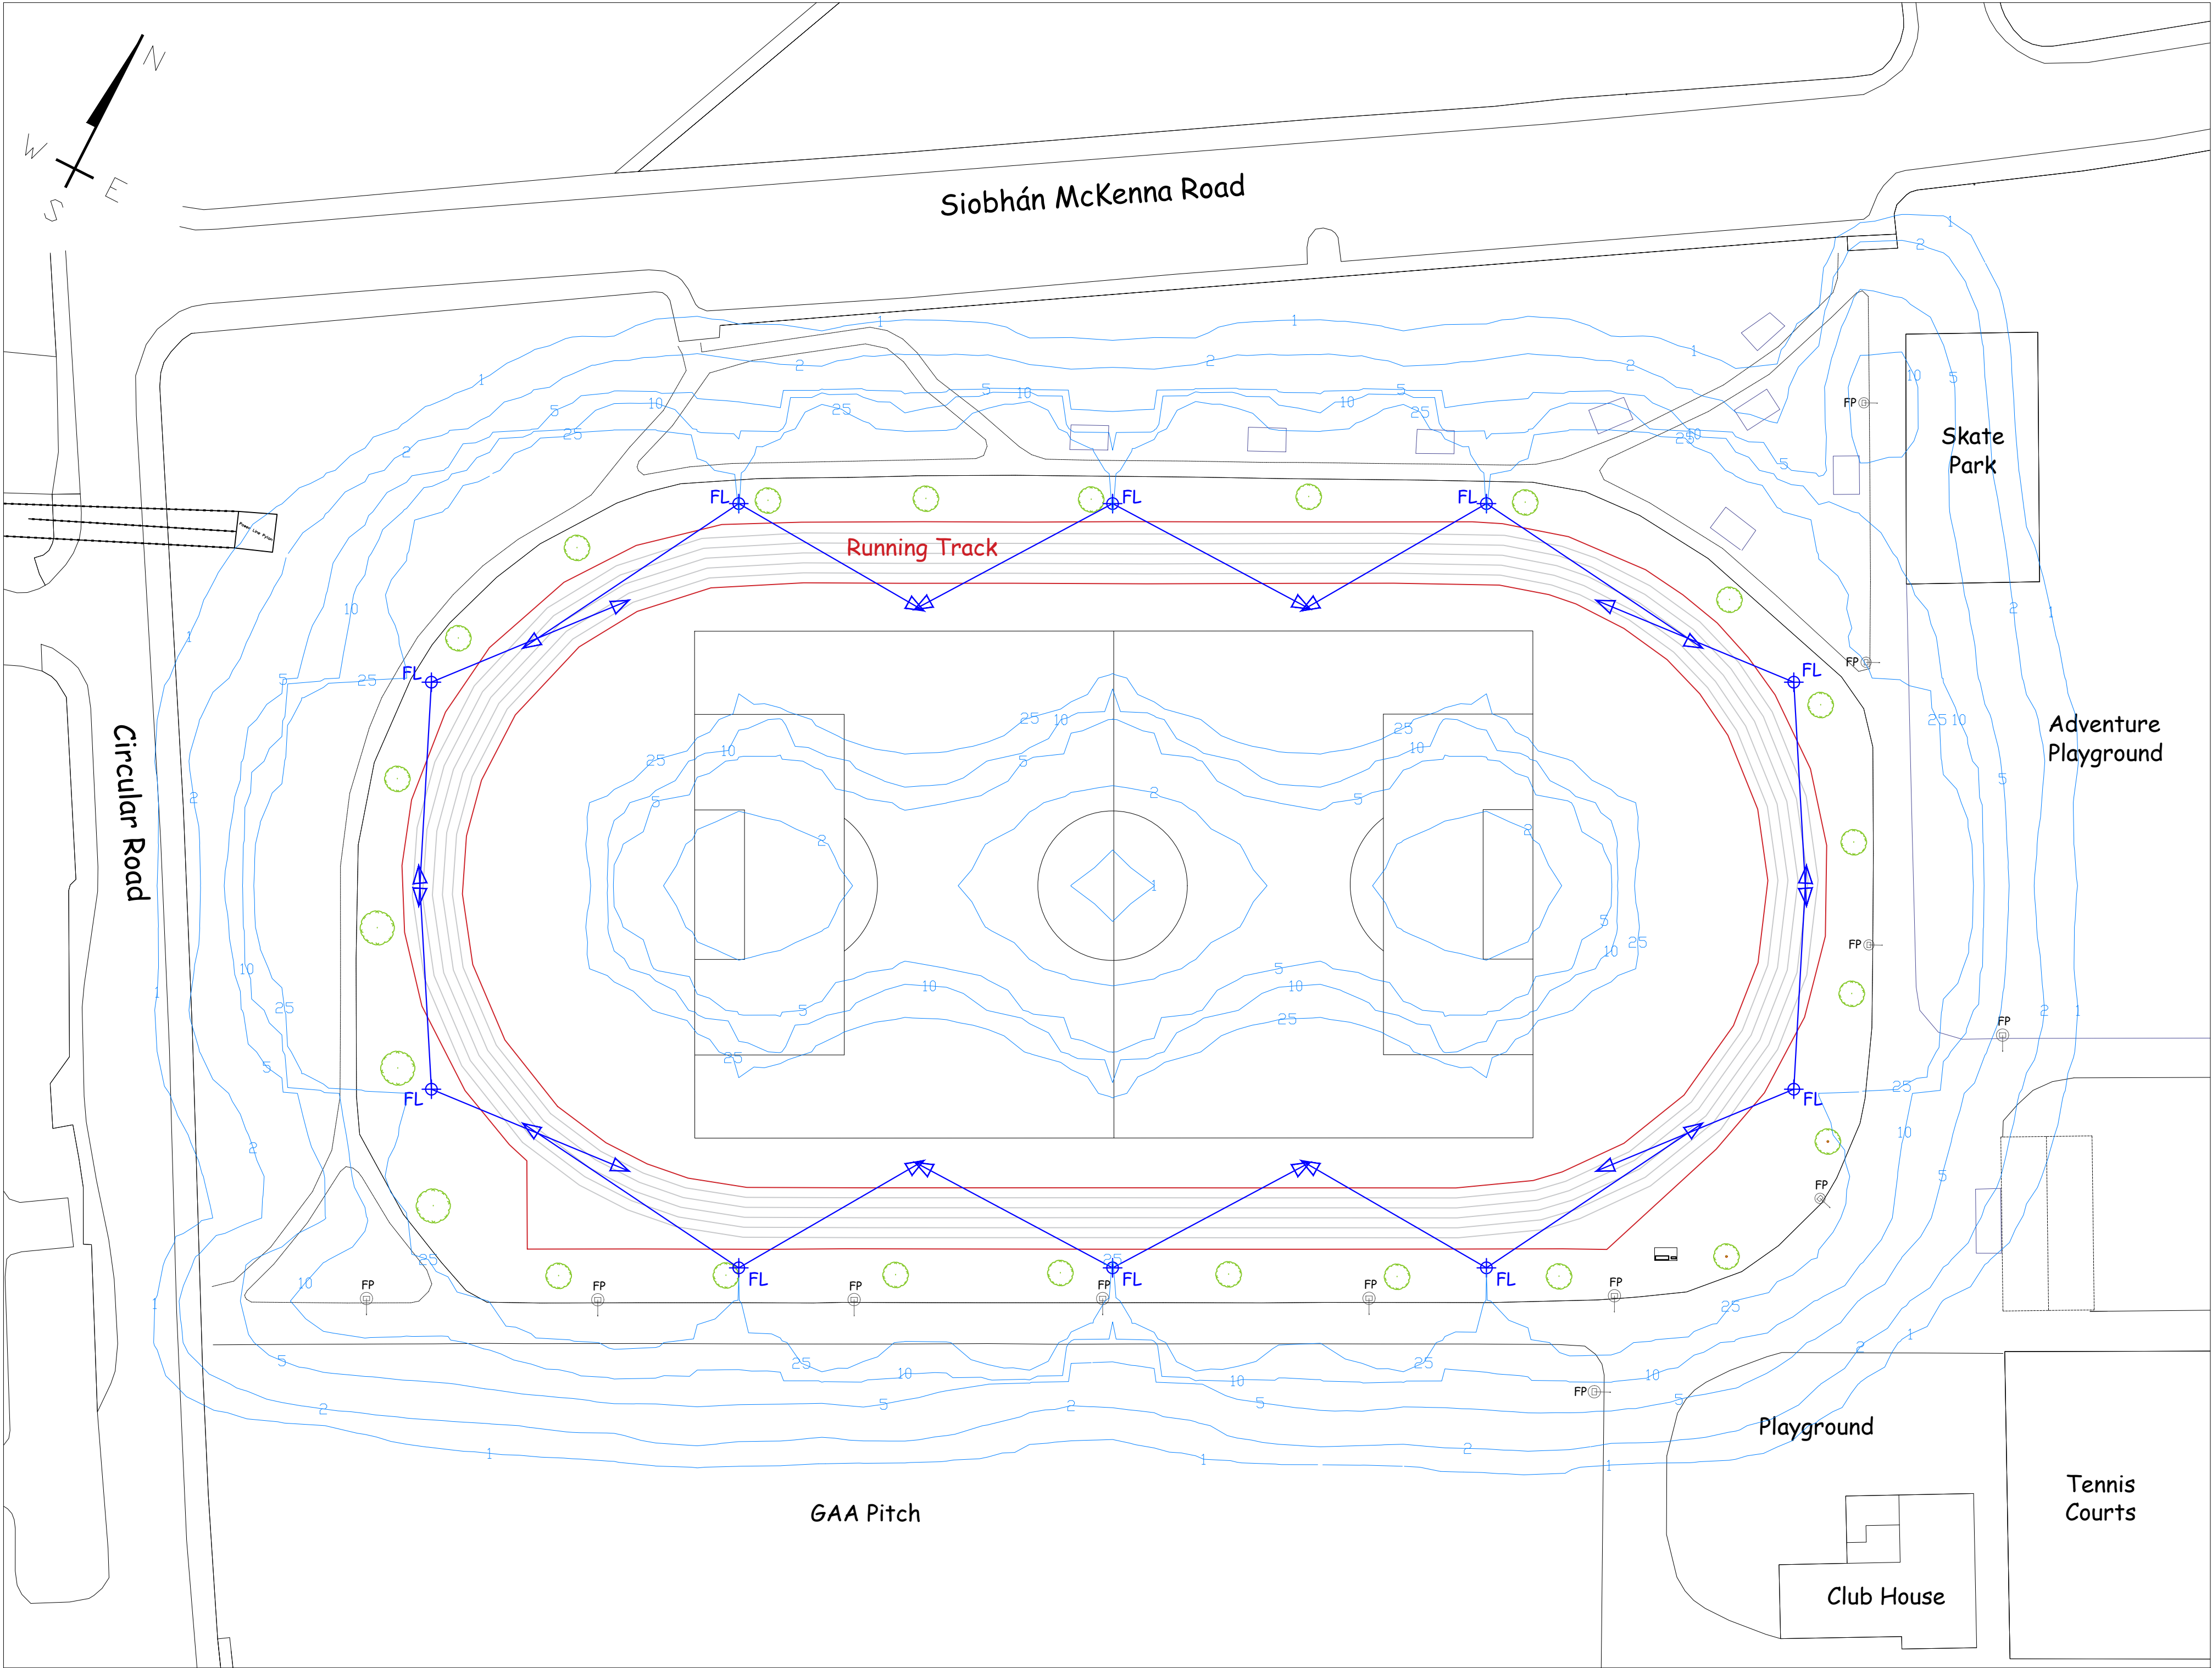


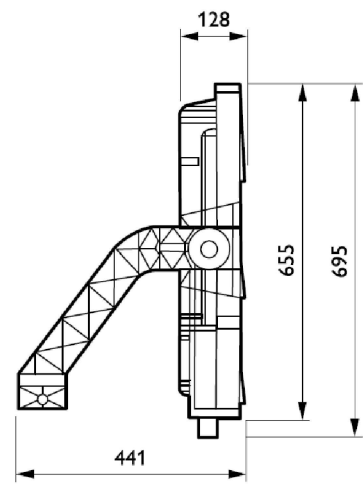


Track Lighting - Overspill Iso Contours
Scale 1:500

- LEGEND**
- BVP528 OUT T35 A55-NB LO
 - Proposed Track Floodlight
 - Surface Illumance (lux) Contour
 - Existing Footpath Lighting
 - Existing Tree

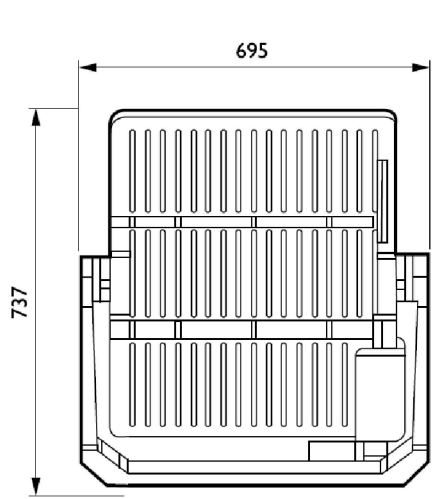

LED Floodlighting
Scale: NTS

Dimensions shown in millimeters (mm).

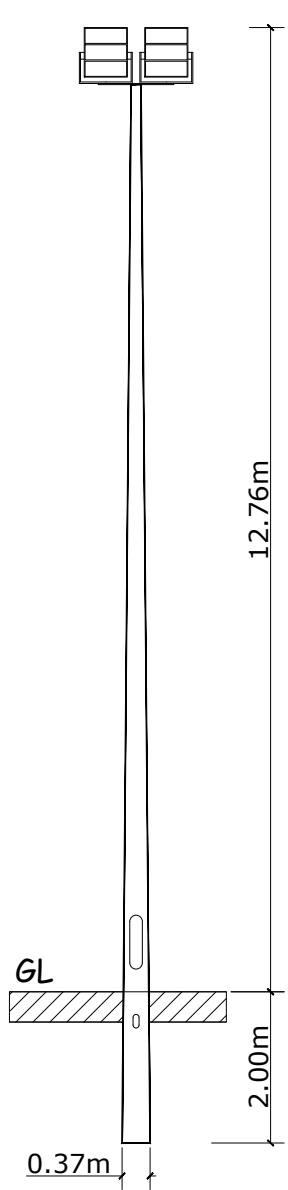

12m High Floodlight Pole
Scale: 1:100

DESCRIPTION	CHK	STA	DATE	REV

NOTES:

PROJECT: Westside Running Track Lighting	LOCATION: Westside Park, Seamus Quirke Road, Galway.
DRAWING: Proposed Lighting Layout	DWG NO.: PKS21-02-003
PROJECT NO.: PKSCAP21-02	SCALE: 1:500 @ A1
DATE: Feb 2024	DRAWN BY: DB
	APPROVED BY: JH