




THIS DRAWING PRODUCED FOR THE BENEFIT OF INDICATING EXISTING GROUND LEVELS AND INTERPRETED ROCK LEVELS / REFUSAL FROM IGSL SITE INVESTIGATION REPORT. ALL SECTIONS THROUGH STRUCTURE ARE SHOWN INDICATIVE & ARE SUBJECT TO DETAILED DESIGN WHEN LAYOUTS ARE FROZEN

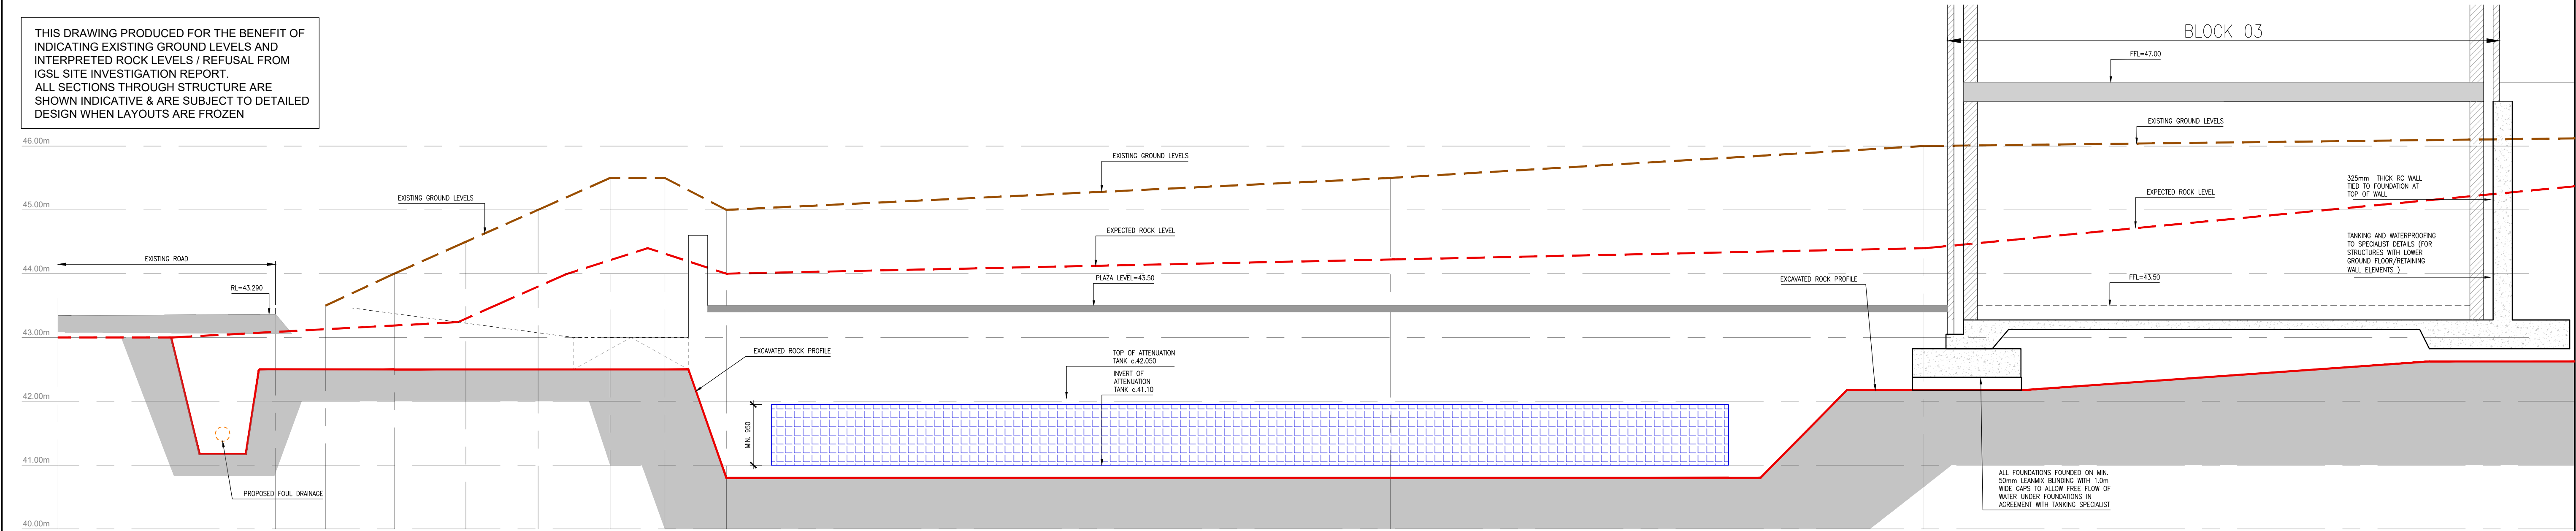

03 SECTION 3-3 INDICATIVE SECTION THROUGH BLOCK 03, PLAZA & ROAD SCALE 1:50

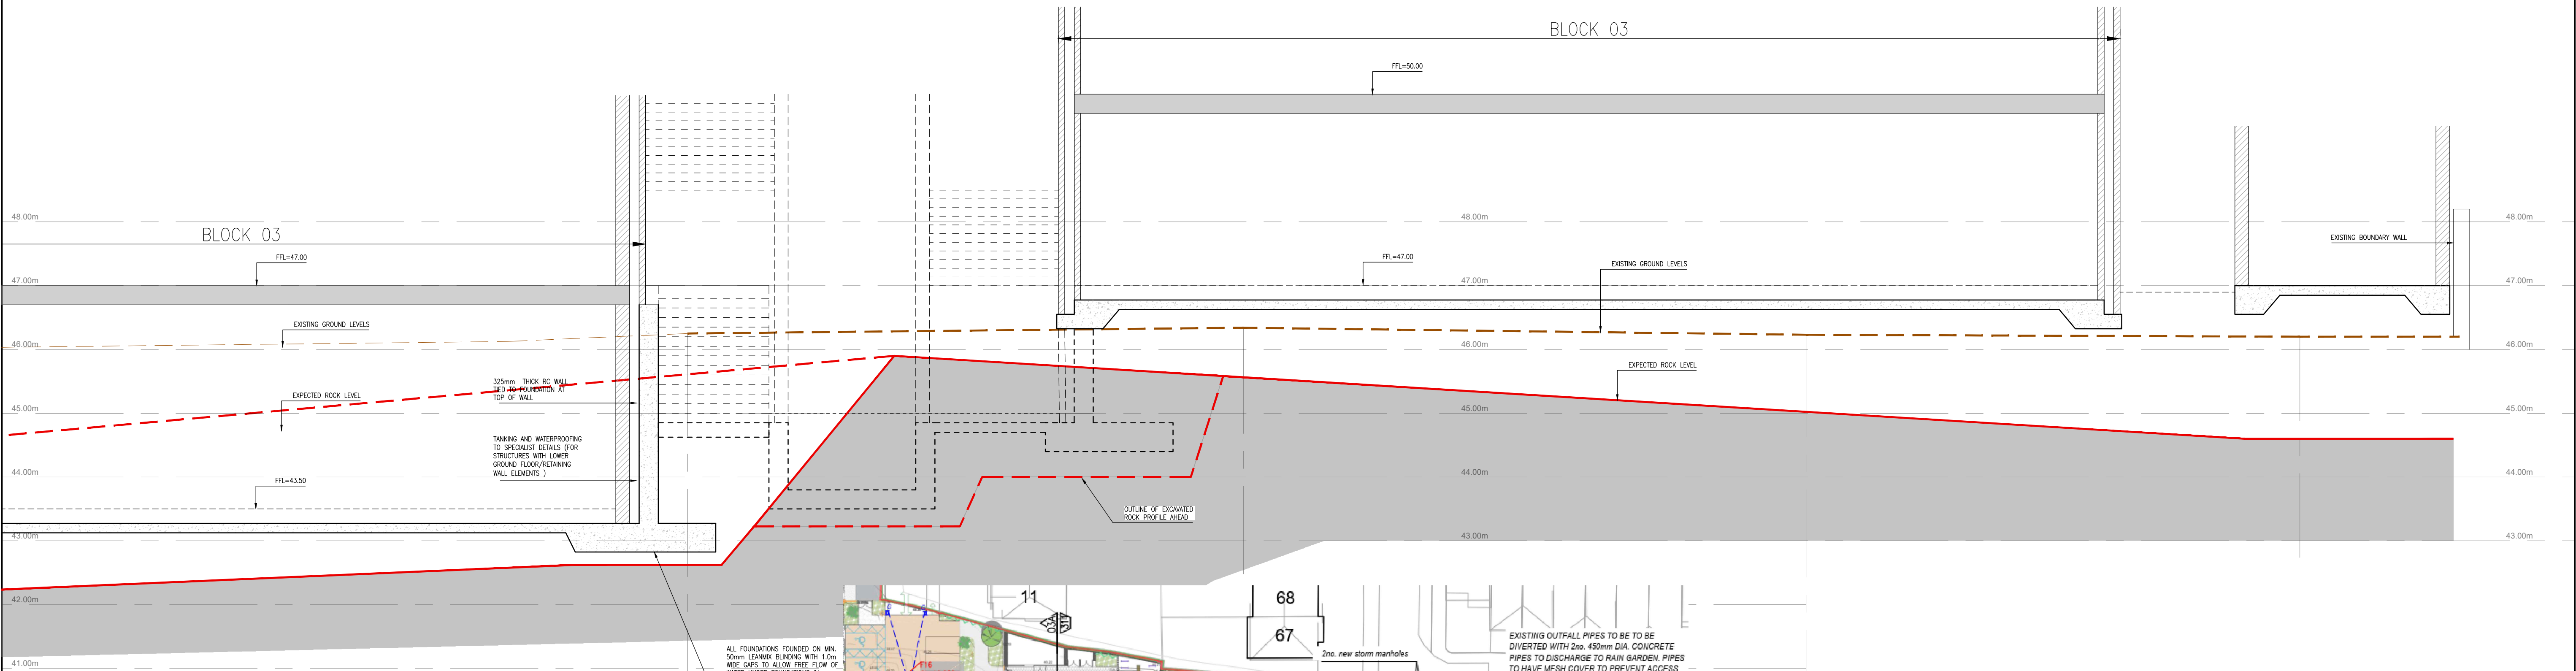

03A SECTION 3A-3A INDICATIVE SECTION THROUGH BLOCK 03, PLAZA & ROAD SCALE 1:50

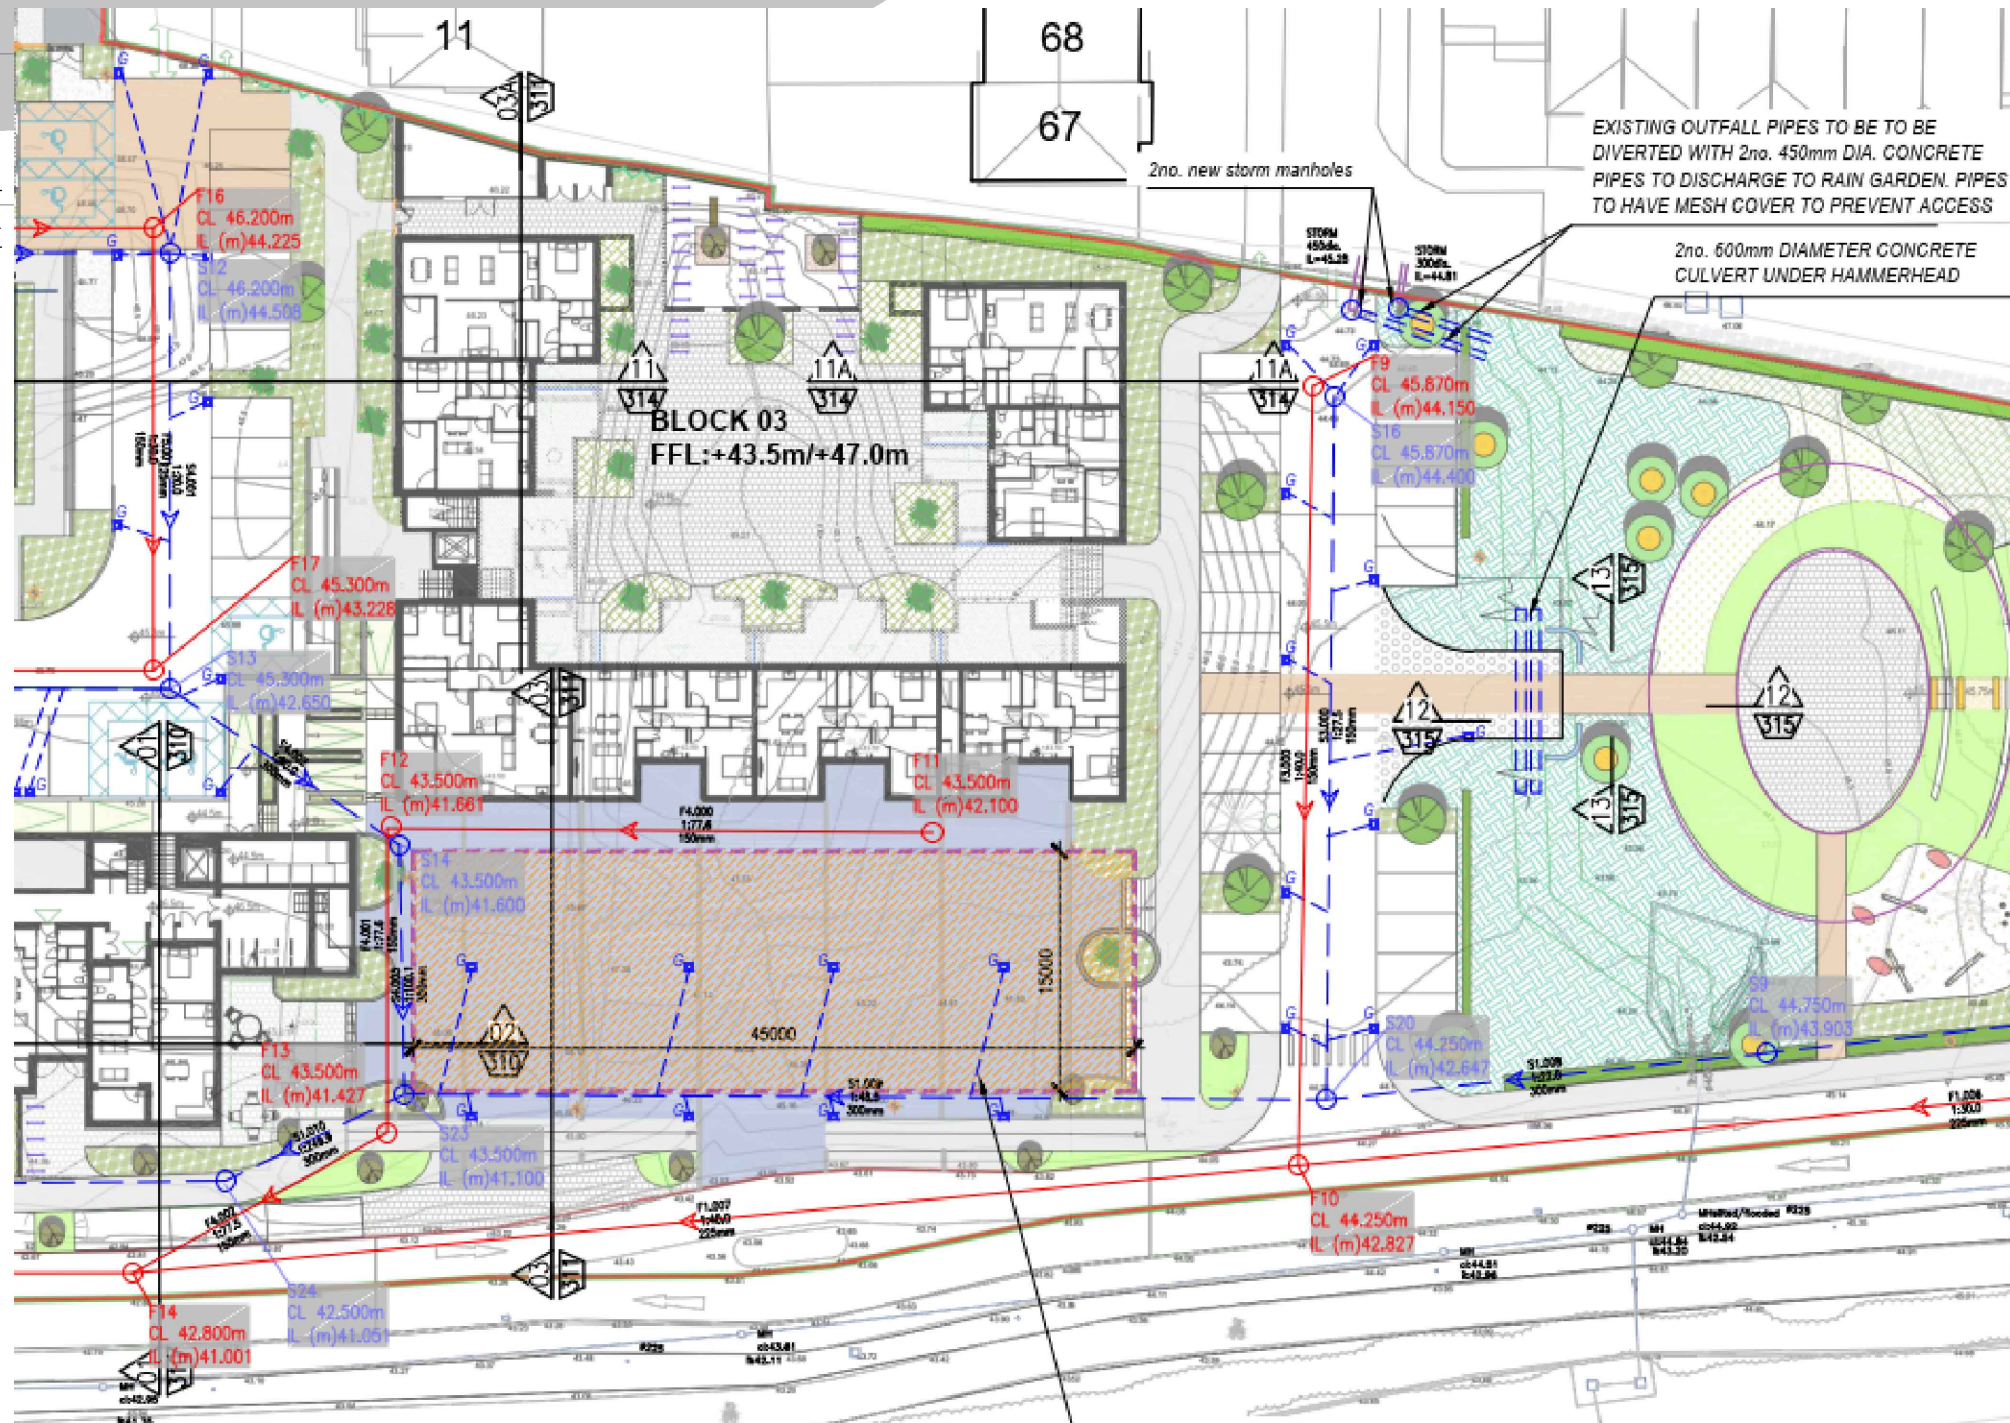


PARTIAL KEY PLAN BLOCK 3 ENTRANCE

GENERAL NOTES :

1. ALL COYLE KENNEDY DRAWINGS TO BE READ IN CONJUNCTION WITH ARCHITECTS DRAWINGS AND ALL OTHER RELEVANT DRAWINGS.
2. ALL SETTING OUT, INSULATION, DPC, TANKING / WATERPROOFING, SCREED AND RADON PROTECTION DETAILS BY ARCHITECT & SPECIALIST.
3. DETAILED SPECIFICATIONS (IF NOT ISSUED) ARE AVAILABLE AT ENGINEERS OFFICE FOR INSPECTION BY CONTRACTORS, BY APPOINTMENT.
4. REFER TO ARCHITECT FOR DAMP PROOF, TANKING AND GAS PROOFING MEMBRANE REQUIREMENTS. REQUIREMENTS OF SUBSTRUCTURE GAS/WATER PROOFING MEMBRANES TO BE BY A REPUTABLE, COMPETENT SPECIALIST WITH ADEQUATE PI.
5. THE CONTRACTOR SHALL BE DEEMED TO HAVE ALLOWED FOR, WITHIN HIS TENDER, EMPLOYING A CHARTERED STRUCTURAL ENGINEER WITH ADEQUATE PROFESSIONAL INDEMNITY INSURANCE TO ASSESS, DESIGN AND DETAIL SUCH TEMPORARY WORKS AS ARE NECESSARY TO OFFER SUPPORT TO EXISTING AND/OR CONSTRUCTED ELEMENTS DURING THE CONSTRUCTION PERIOD. THIS APPLIES TO ELEMENTS WITHIN THE SITE AND NEIGHBORING THE SITE.
6. THE CONTRACTOR IS DEEMED TO HAVE VISITED THE SITE AND CONSULTED WITH RELEVANT AUTHORITIES AND BE SATISFIED IN RELATION TO THE SITE SURROUNDINGS, EXISTING SERVICES, LEVELS, BOUNDARIES, GROUND CHARACTERISTICS AND ANY OTHER SITE CONSTRAINTS, INCLUDING DIVERSION OF SERVICES AS NECESSARY.
7. ALL WORK TO BE CARRIED OUT IN ACCORDANCE WITH THE CURRENT BUILDING REGULATIONS.
8. WHERE LEANMIX IS SPECIFIED ALL LEANMIX TO BE GRADE C16/20 (GEN 3) UNLESS NOTED OTHERWISE.
9. ALL LEVELS ARE IN METRES ABOVE ORDNANCE DATUM (U.N.O.) INDICATING STRUCTURAL LEVEL (SSL).
10. DO NOT SCALE FROM DRAWINGS, USE FIGURED DIMENSIONS ONLY. ANY DISCREPANCIES TO BE REPORTED TO THE STRUCTURAL ENGINEER PRIOR TO COMMENCEMENT OF WORKS.
11. FOR PARTITION RESTRAINTS & FLOOR DETAILS SEE ARCHITECTS DRAWINGS.
12. ALL WORKS SHALL BE CARRIED OUT IN A SAFE MANNER AND IN ACCORDANCE WITH THE HEALTH AND SAFETY REGULATIONS. METHOD STATEMENTS (WHERE REQUIRED) SHALL BE SUBMITTED TO THE ENGINEER OR OTHER APPOINTED PERSON(S).

13. THE CONTRACTOR SHALL COMPLY WITH ALL STATUTORY AUTHORITY REQUIREMENTS INCLUDING PLANNING CONDITIONS, FIRE SAFETY CERTIFICATE CONDITIONS, LOCAL AUTHORITY DRAINAGE REQUIREMENTS ETC.
14. PROJECT DRAWINGS AND SPECIFICATIONS REFERENCE TO BUILDING REGULATIONS, BRITISH, IRISH OR OTHER NATIONAL STANDARD OR CODES OF PRACTICE DO NOT GIVE THE YEAR OF ISSUE OR DATES OF AMENDMENTS. THE LATEST RELEVANT PUBLISHED VERSION INCLUDING ANY RELEVANT AMENDMENTS AND ADD END AT THE DATE OF INVITATION TO TENDER SHALL APPLY, WHERE A STANDARD OR CODE OF PRACTICE HAS BEEN SUPERSEDED, THE LATEST EDITION OF THE SUPERSEDING PUBLICATION SHALL APPLY.
15. ANY DISCREPANCIES DISCOVERED BETWEEN DESIGN TEAM DRAWINGS TO BE REPORTED IMMEDIATELY AND CLARIFICATION SOUGHT AND DISCREPANCY CORRECTED PRIOR TO CONSTRUCTION COMMENCING.
16. REFER TO ARCHITECTS DRAWINGS FOR RESTRAINT OF NON-LOADBEARING PARTITIONS, NON-LOADBEARING PARTITIONS SHOULD NOT BE BUILT UP DIRECTLY TO THE UNDERSIDE OF THE LOAD CARRYING STRUCTURE, ALLOW A MINIMUM OF 25mm DEFLECTION UNLESS NOTED OTHERWISE.
17. ALL WORKS TO BE CARRIED IN A PROPER AND SAFE MANNER AND IN ACCORDANCE WITH HEALTH AND SAFETY REGULATIONS.
18. FIRE RATINGS AND FIRE PROTECTION DETAILS TO STRUCTURAL STEEL, TIMBER, COMPOSITE SLAB (METAL DECK) ETC SHALL BE AS DEFINED AND DETAILED BY THE ARCHITECT / FIRE OFFICER REQUIREMENTS AND REGULATIONS.
19. ONLY BUILDING WORKS OPENINGS SHOWN AT THE LOCATIONS ON COYLE KENNEDY LTD STRUCTURAL ENGINEERS DRAWINGS ARE ALLOWED TO BE CONSTRUCTED. ADDITIONAL OPENINGS WILL REQUIRE DESIGN CHECK AND CONSENT FROM COYLE KENNEDY LTD PRIOR TO CONSTRUCTION. HOLES OR OPENINGS OTHER THAN THOSE SHOWN ON THE STRUCTURAL ENGINEERS DRAWINGS MUST NOT BE CONSTRUCTED WITHOUT CONSENT.
20. MINIMUM CONCRETE STRENGTH U.N.O. C30/37 - REFER TO 000 NOTES DRAWING

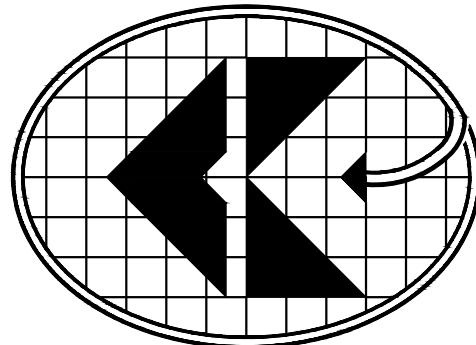

COYLE KENNEDY
Consulting Engineers

GFSC,
Moneenageisha Rd,
Galway.

Tel: +353 (0)91 752000
Fax: +353 (0)91 753000

Website: www.coylekennedy.com
email: mail@coylekennedy.com

Rev.	Revision	Date
B	SECTIONS UPDATED IN ACCORDANCE WITH REVISED SITE LAYOUT	06/12/2023
A	SECTIONS UPDATED IN ACCORDANCE WITH REVISED SITE LAYOUT	28/02/2023

DRAWING STATUS		
P PRELIMINARY	A APPROVAL	T TENDER
C CONSTRUCTION	R RECORD	I INFORMATION

PROJECT	BALLYBURKE NEIGHBOURHOOD CENTRE AND SOCIAL HOUSING SCHEME	
---------	---	--

CLIENT	GALWAY CITY COUNCIL	
--------	---------------------	--

TITLE	SITE SECTIONS SHEET 2	
-------	-----------------------	--

PROJECT No.	21-150	STATUS - DRAWING No.	
DATE	FEBRUARY 2023	P-311	
SCALE	1:50, @ A1	BY	AC
		CHECKED	BC
		DRAWING REV.	
		B	