


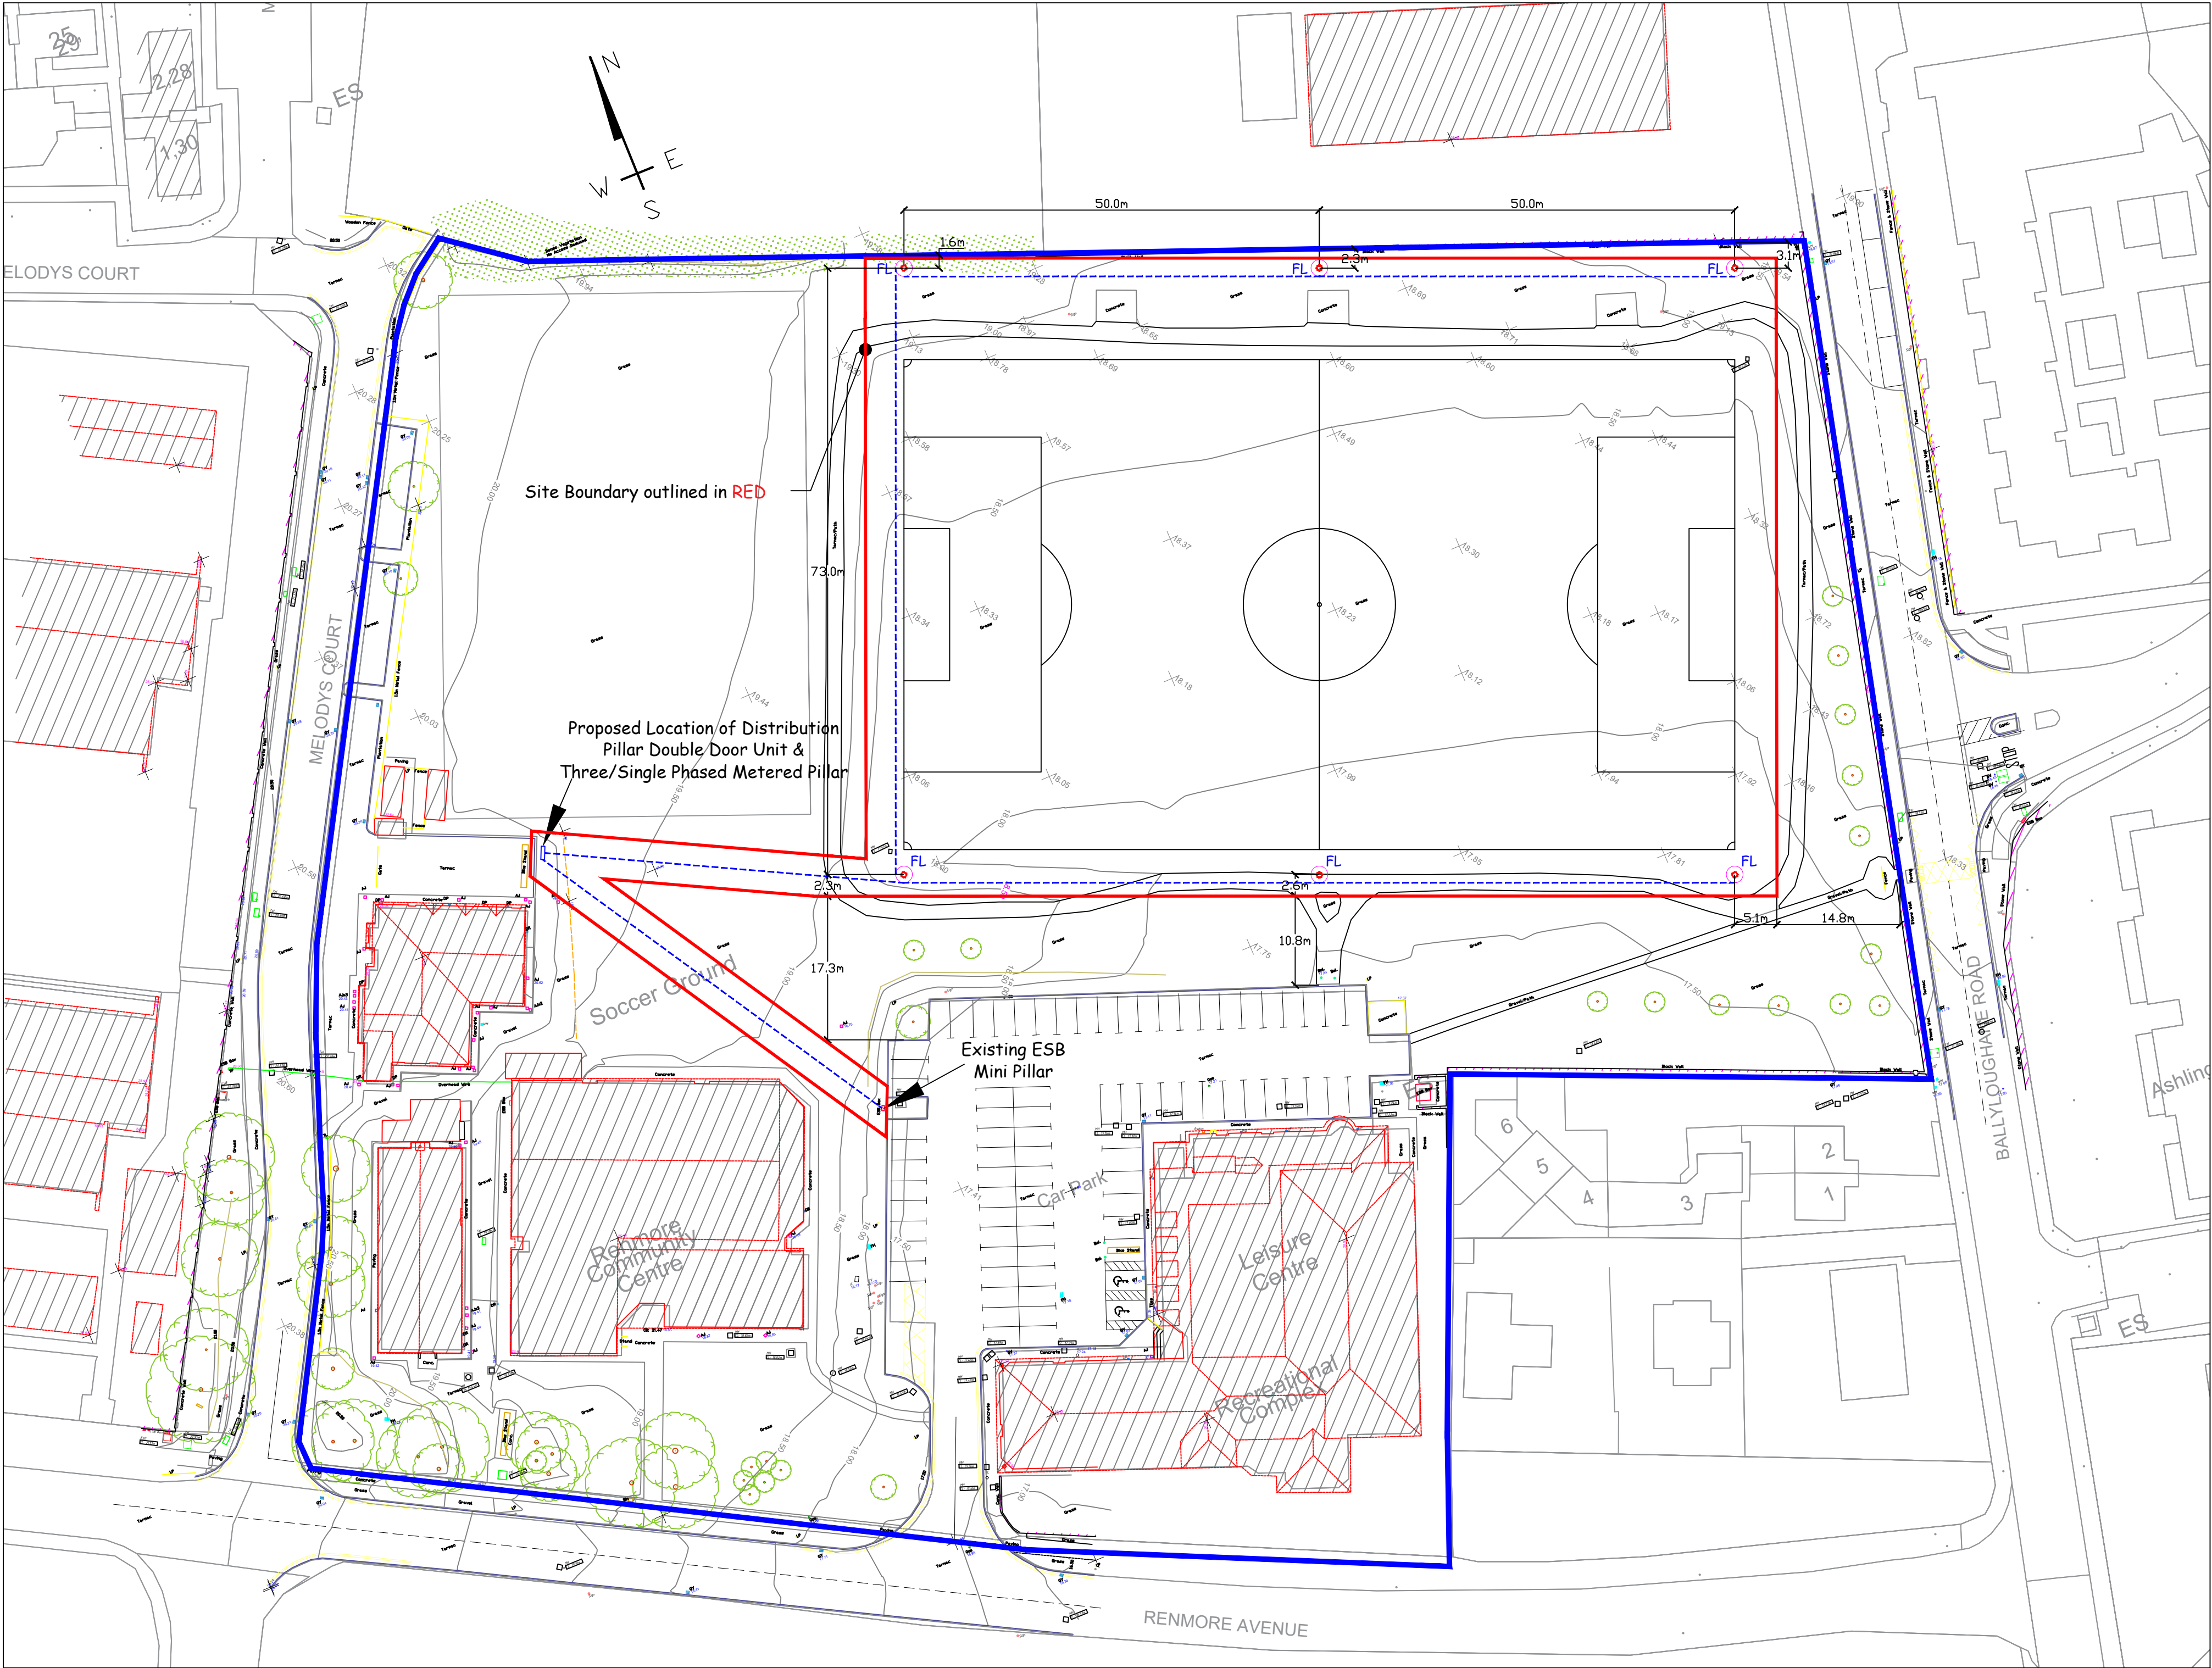

Pitch Lighting - Site Layout
Scale 1:500

LEGEND

- 125mm Ø Ducting Run

Proposed Floodlight

Existing Tree
- FL
- Existing Level


Contour Line




Distribution Pillar Double Door
1600mm High x 1600mm Wide x 450mm Deep
Please refer to enclosed Piltown Engineering Information Sheet



Three/Single Phased Metered Pillar
1270mm High x 600mm Wide x 225mm Deep
Please refer to enclosed Piltown Engineering Information Sheet

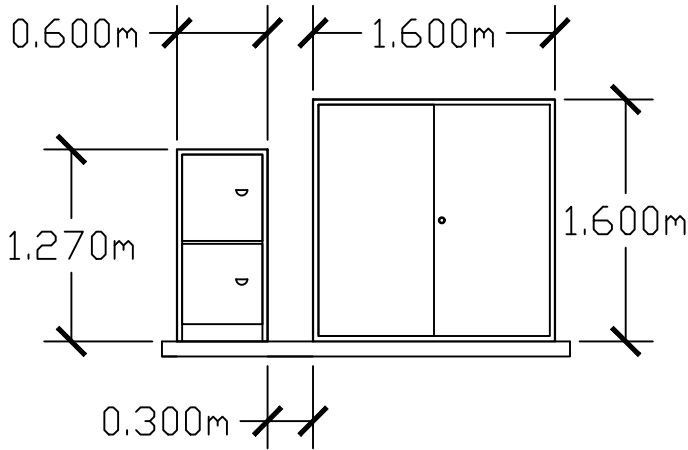

Front Elevation

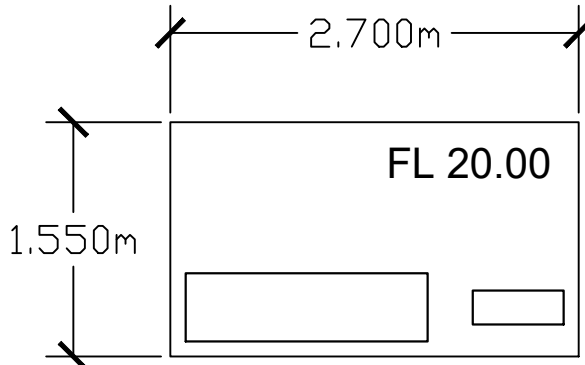

Plan

Layout for Distribution & Metered Panels
Scale: 1:50

Panels to be placed on 100mm Concrete Plinth as shown at Finished Level of 20.00.

DESCRIPTION	CHK	STA	DATE	REV	

NOTES:
DO NOT SCALE FROM THIS DRAWING. WORK ONLY FROM FIGURED DIMENSIONS.
ALL ERRORS AND OMISSIONS TO BE REPORTED TO THE DESIGNER.
EXTRACT O.S. SHEETS 3409 01 & 3409 06
© ORDNANCE SURVEY IRELAND. ALL RIGHTS RESERVED.

PROJECT:	Melody's Field Floodlighting	LOCATION:	Renmore, Galway
DRAWING:	Site Layout	DWG NO.:	PKS24-09-002
PROJECT NO.:	PKSCAP24-09	SCALE:	1:500 @ A1
DATE:	May 2025	REV:	A
		DRAWN BY:	KM
		APPROVED BY:	JB